
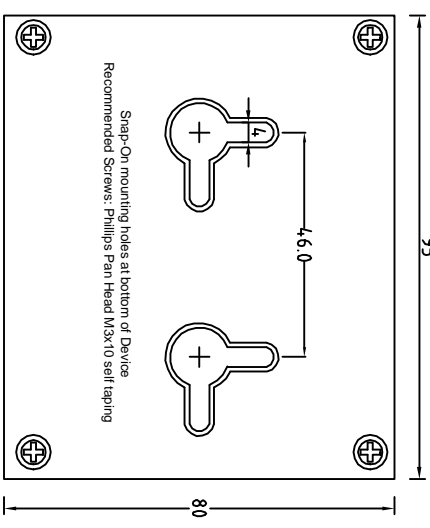
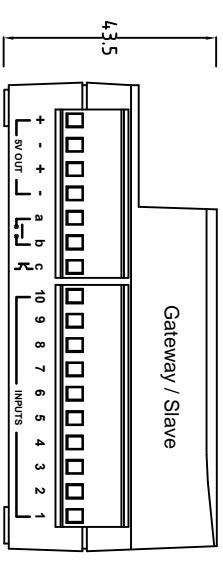
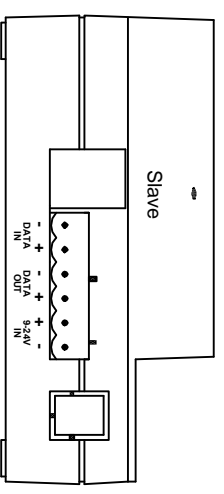
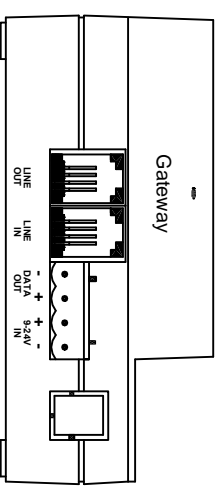


iSCADA Installation Schematics for Chiller Room

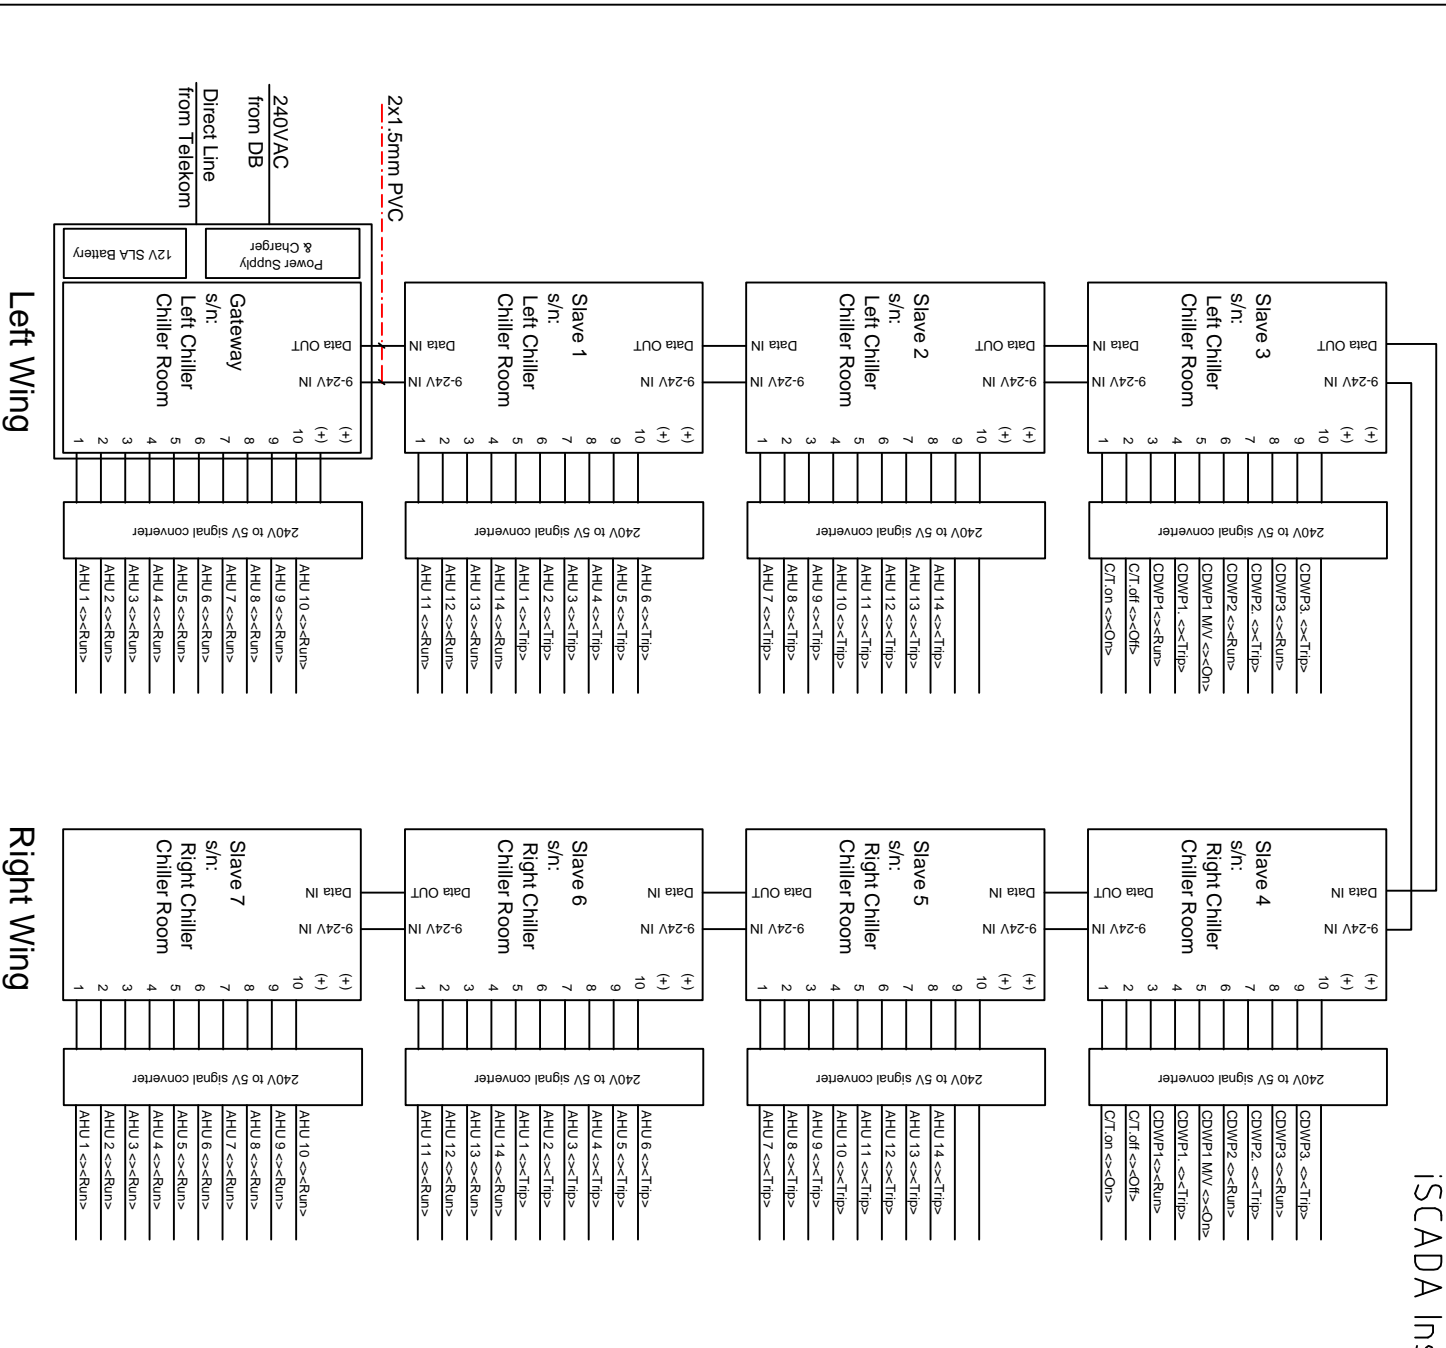

Title: iSCADA Monitoring System			
Single Line Diagram			
Fire Alarm Console			
Client:	Date:	Drawn:	App'd:
Notes:	Scale: N.T.S.	Drawn Date:	Rev: 1.0